


**DETAIL 1
FRONT VIEW**

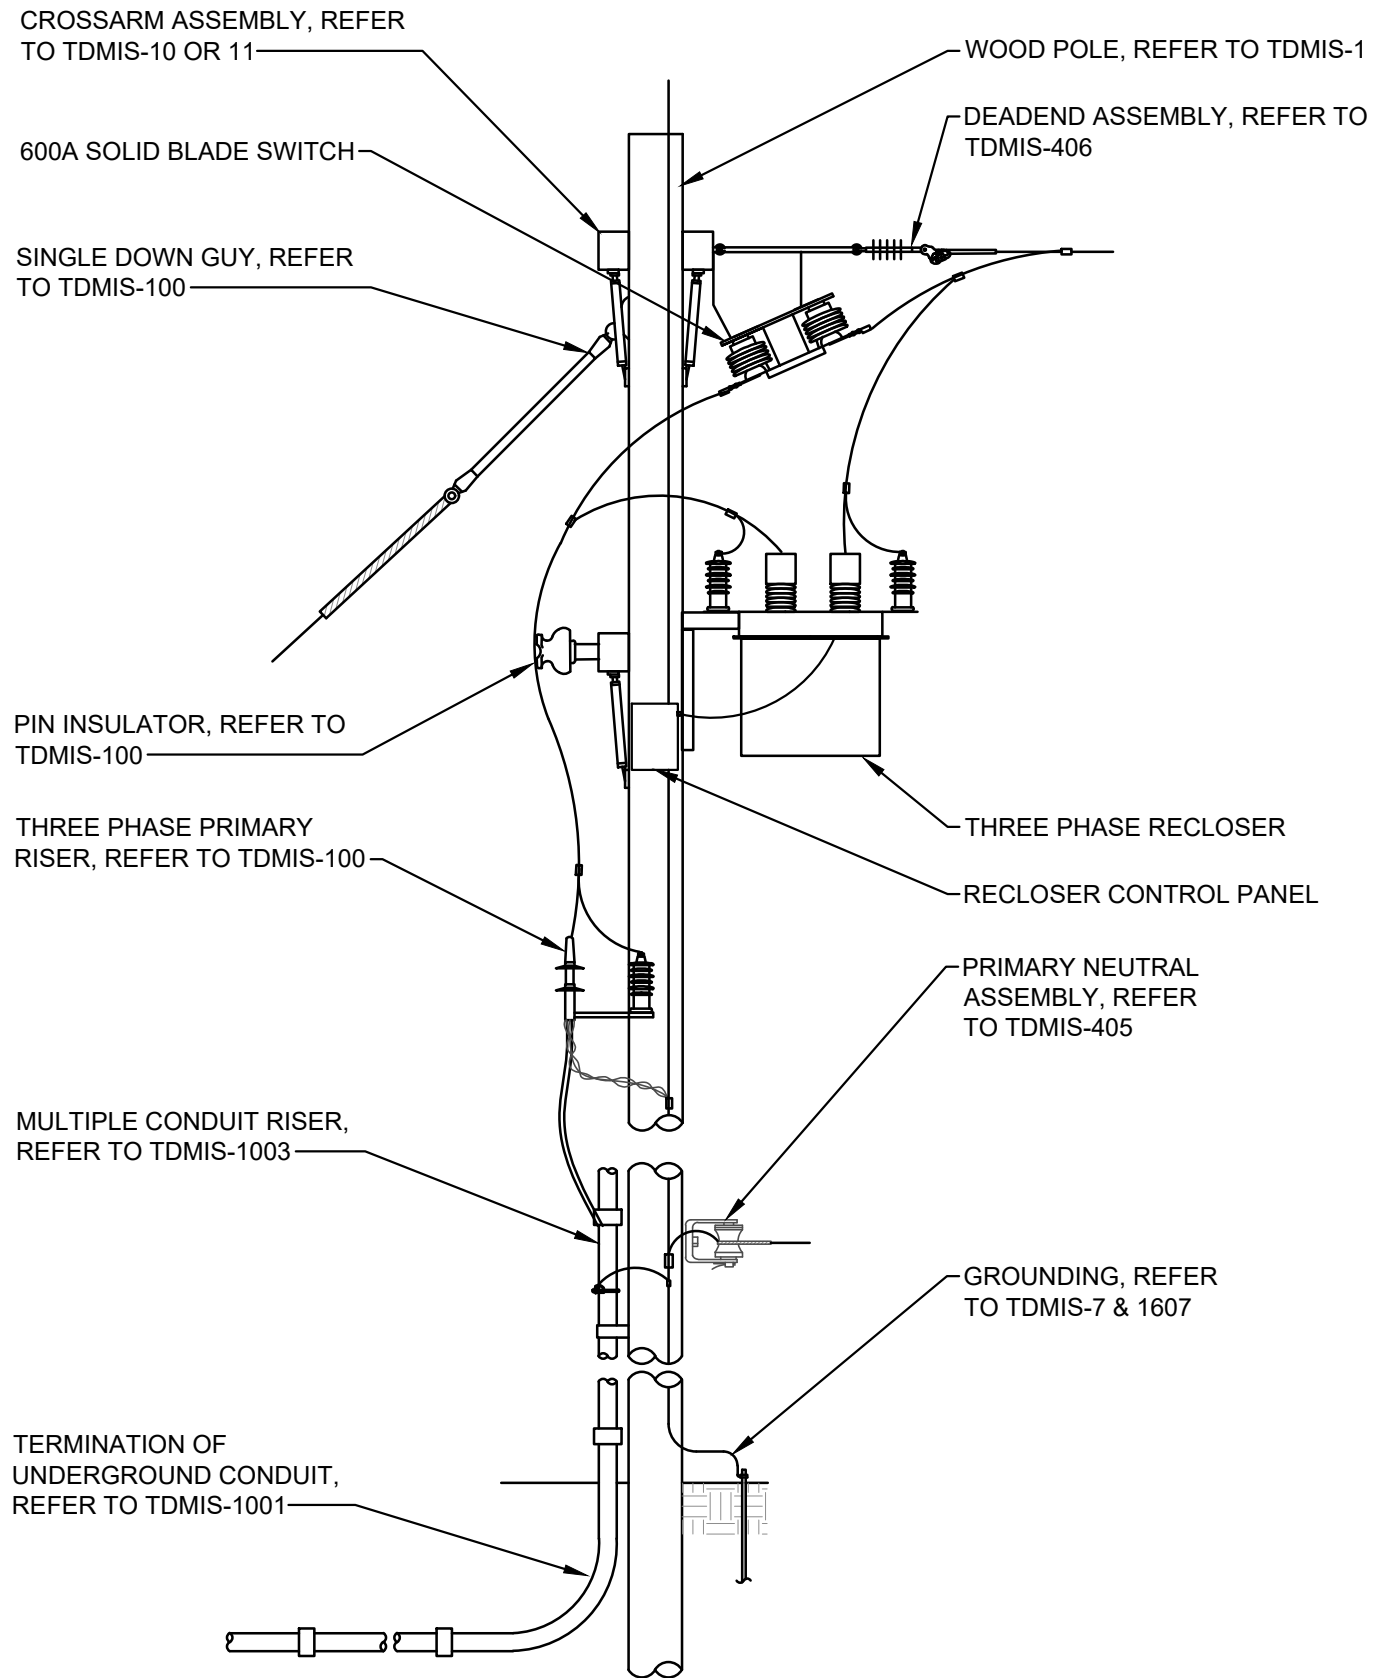

**DETAIL 2
SIDE VIEW**

GENERAL NOTES:

1. THE CITY WILL PAY FOR ALL WORK INSTALLED AS SPECIFIED IN THIS DRAWING ACCORDING TO THE APPROPRIATE CONTRACT ITEMS FOR EACH COMPONENT OF THE WORK.

REFERENCE LIST

TDMIS	DESCRIPTION
1	WOOD POLES
7	OVERHEAD DISTRIBUTION CIRCUIT GROUNDING
10	WOOD CROSSARM- WOOD BRACES
11	WOOD CROSSARM- STEEL BRACES
20	PIN AND PIN INSULATOR
24	COPPER CONDUCTOR HAND-MADE INSULATOR TIES
25	ALUMINUM CONDUCTOR HAND-MADE INSULATOR TIES
100	SINGLE DOWN GUY & ANCHOR WITH INSULATOR
405	PRIMARY NEUTRAL ASSEMBLY
406	DEADEND ASSEMBLY
1001	RISER POLE
1303	THREE PHASE PRIMARY RISER- 600A
1607	GROUND ROD TEST

CITY OF COLUMBUS, OHIO
DEPT. OF PUBLIC UTILITIES - DIVISION OF POWER

**THREE PHASE DEADEND RISER
WITH RECLOSER & DISCONNECT SWITCHES**

DRAWN BY: DDC DATE: 09/07/2018
APPROVED: R. SPRITE *R. Sprite*
SCALE: NTS SHEET: 1 OF 1

TDMIS-906

THIS DRAWING IS FOR REFERENCE ONLY